



# University of the Philippines OPEN UNIVERSITY

## BIDS AND AWARDS COMMITTEE

 
 
19 March 2024

### SUPPLEMENTAL BID BULLETIN NO. 24-006

This Supplemental Bid Bulletin No. 24-006 is to amend or modify items in the Bid Documents and in response to the queries raised during the pre-bid conference conducted on 14 March 2024 for “Supply, Delivery and Installation of a Brand New 1-Unit 250kVA, 3Phase, 400V Generator Set - Silent Type with Accessories (including Housing) for the ICC” to wit:

Item/Query	Answers
1. Regarding the generator, is it synchronized ready?	It is not synchronized ready. The bidder will provide the synchronization panel and tap it to the existing generator.
2. Regarding the capacity bank, is it included in the generator set?	Capacity bank should be provided by the bidder which will be placed inside the existing low voltage switchgear. Prior to the installation, a shop drawing should be submitted for approval.
3. Existing Model No. of control panel	DSE 6110
4. Warranty period	<ul style="list-style-type: none"><li>- Civil Works - 5 years</li><li>- Genset - 1000 hours operation (500 hours/year) or 2-years parts and labor, or whichever comes first.</li></ul>
5. “Regarding the SLCC, we have no SLCC in civil works but we have SLCCs in gensets supply and installation?”	SLCC is for both generator set and housing in a single project and shall be at least 50% of the completed project similar in nature.
6. Request for an As-built Plan.	See attached as-built plans. Please note that actual measurements and site condition must be verified.

For the guidance and information of all concerned bidders.


  
**Dr. PRIMO G. GARCIA** for  
Chair, BAC 

Received by the Bidder:


\_\_\_\_\_ Date: \_\_\_\_\_  
Signature over printed name

Los Baños, Laguna 4031 Philippines


Tel Nos. +63(49) 536-6001 to 06 local 210 Telefax +63(49) 536-5991 Email: bac@upou.edu.ph

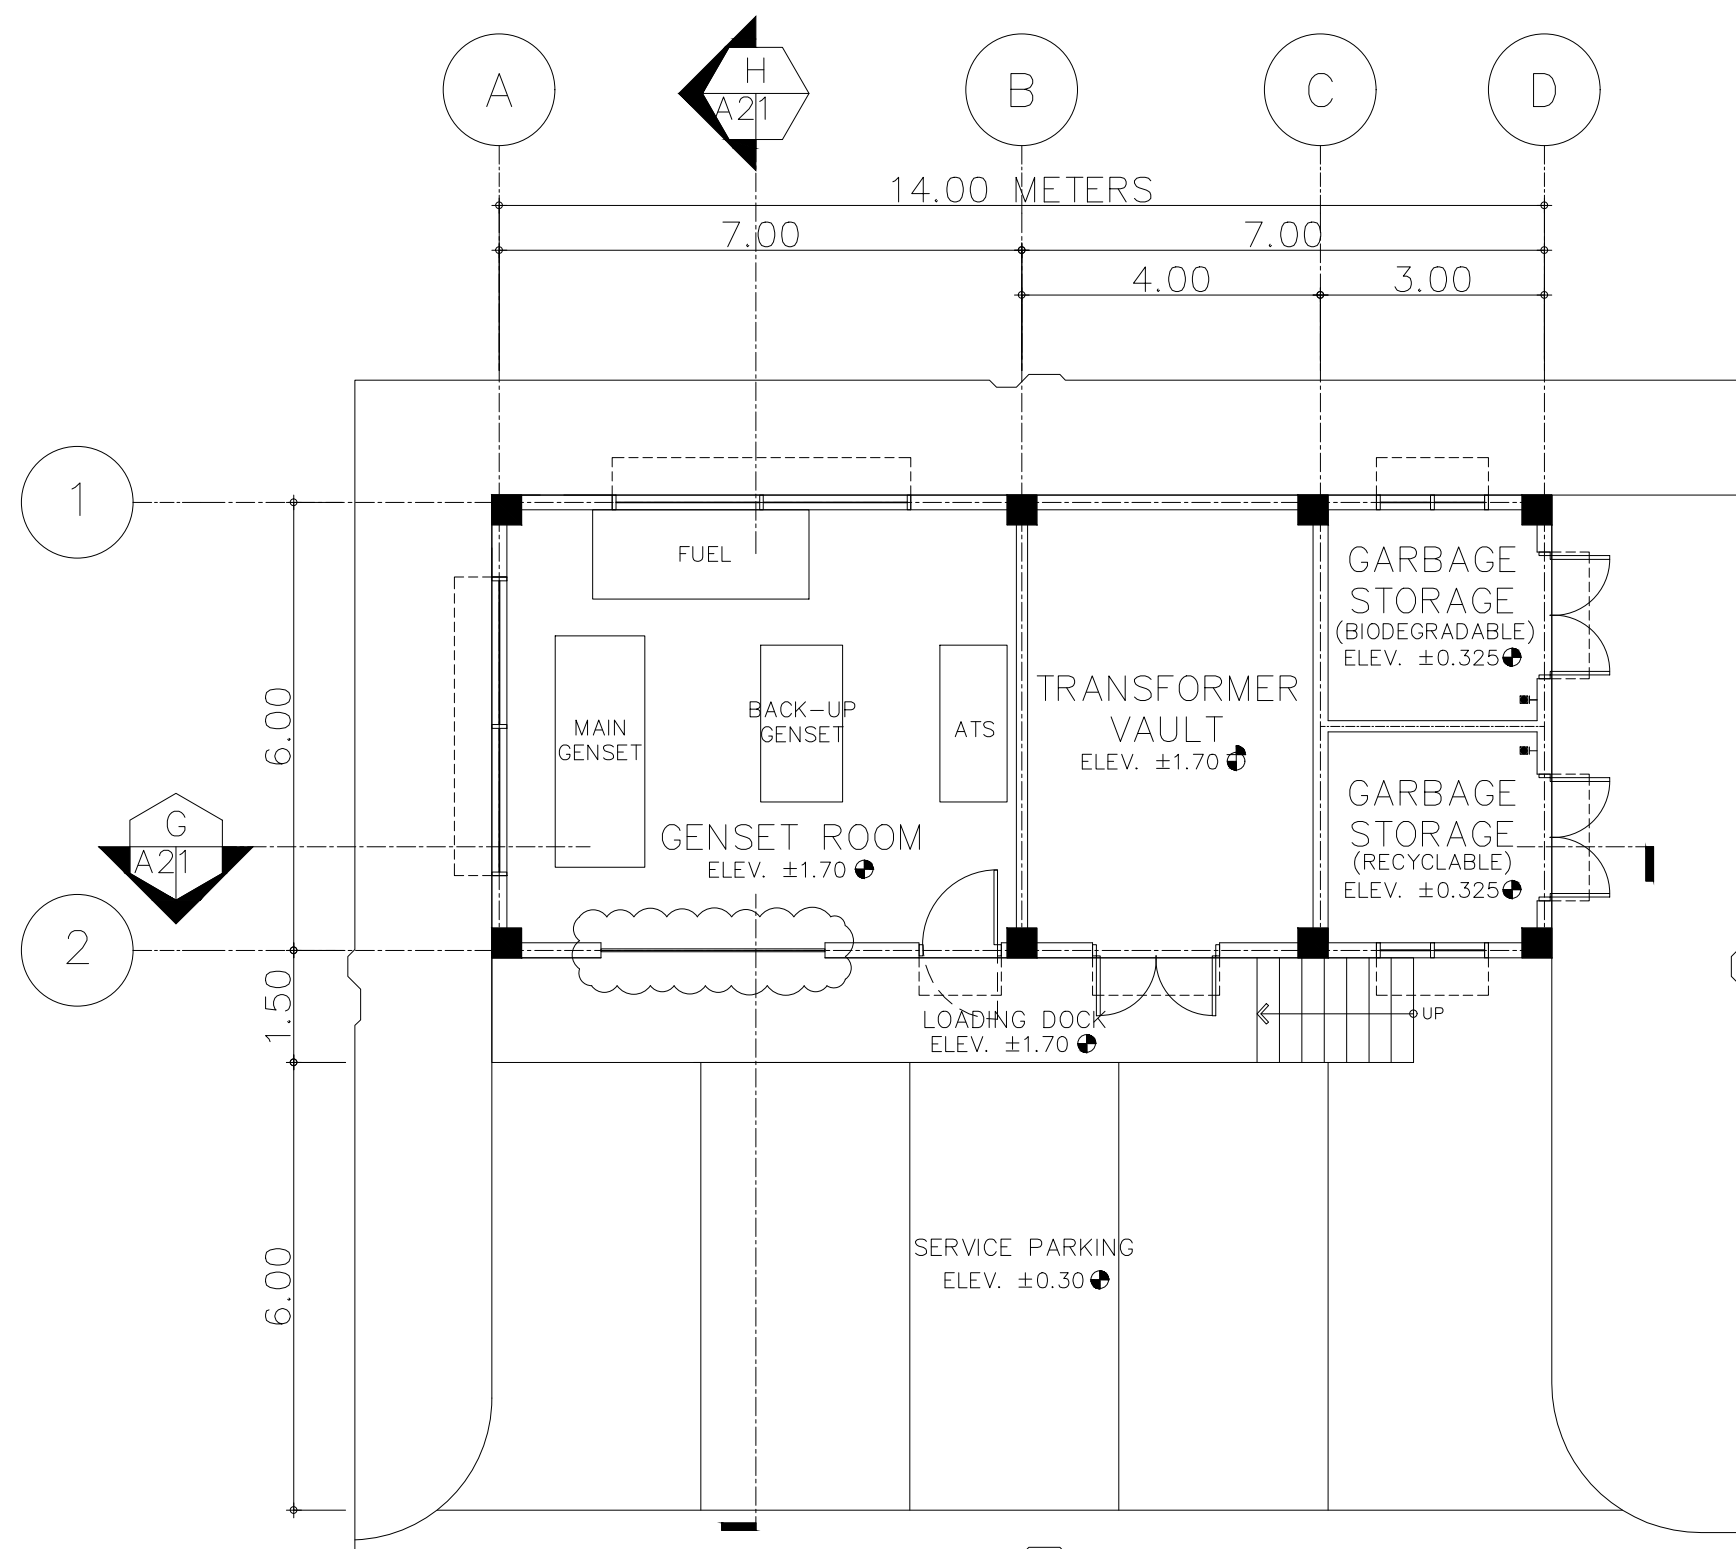


UTILITY BUILDING  
GROUND FLOOR PLAN  
SCALE 1:100M

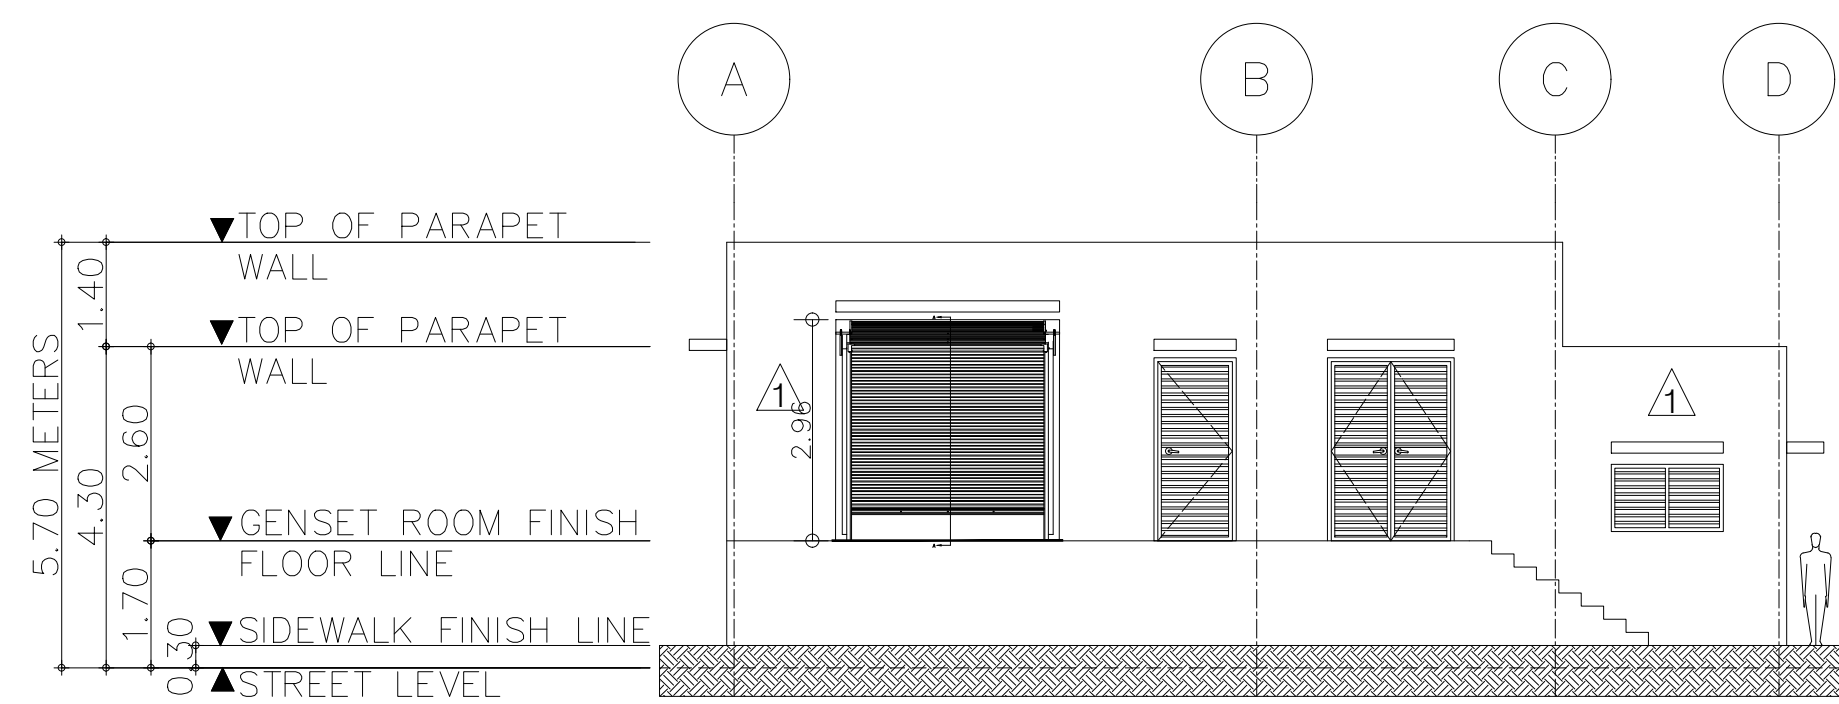


UTILITY BUILDING  
FRONT ELEVATION  
SCALE 1:100M

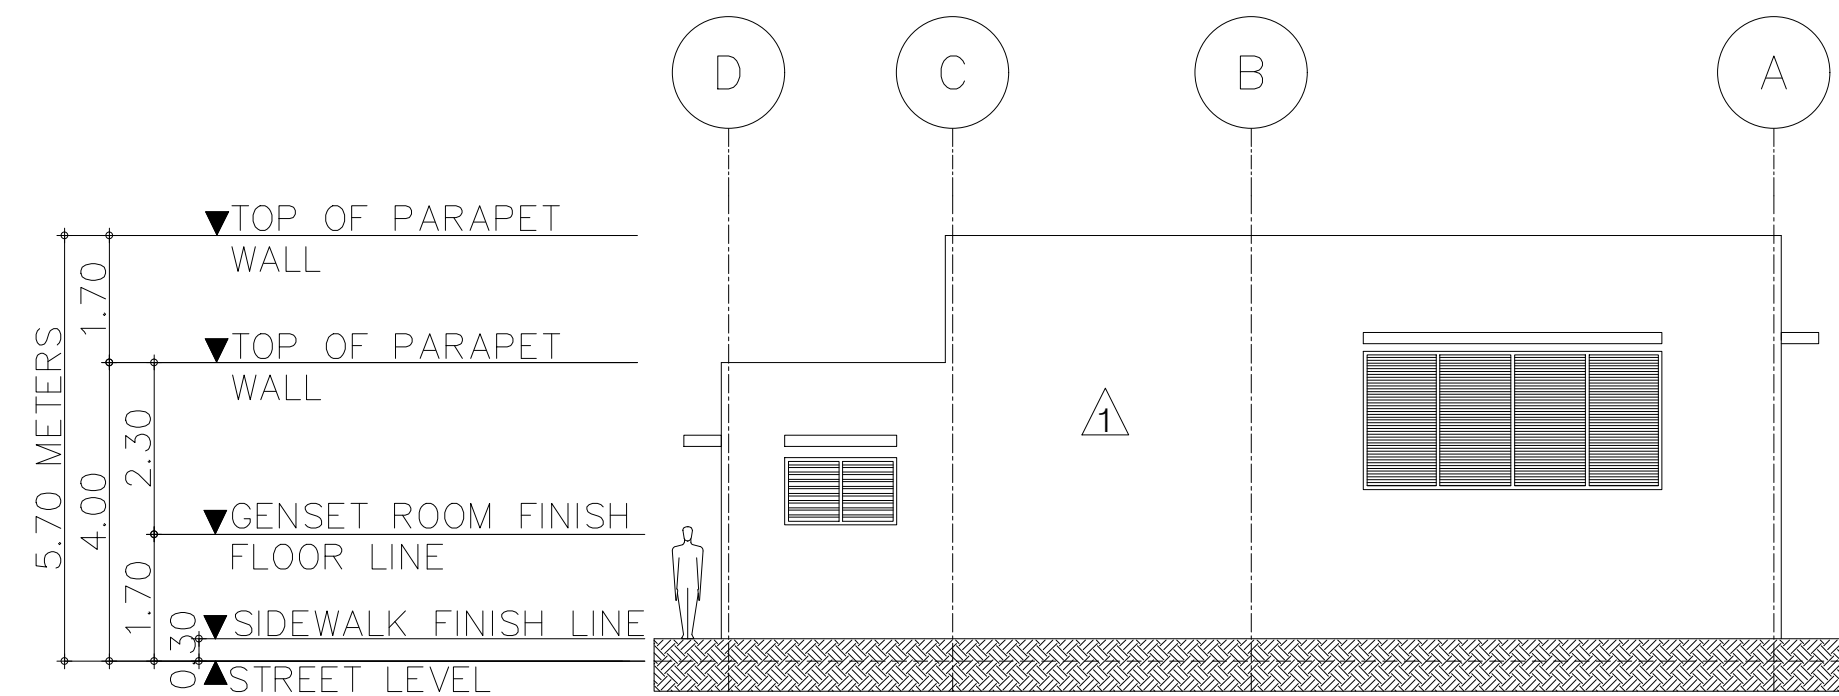


UTILITY BUILDING  
REAR ELEVATION  
SCALE 1:100M

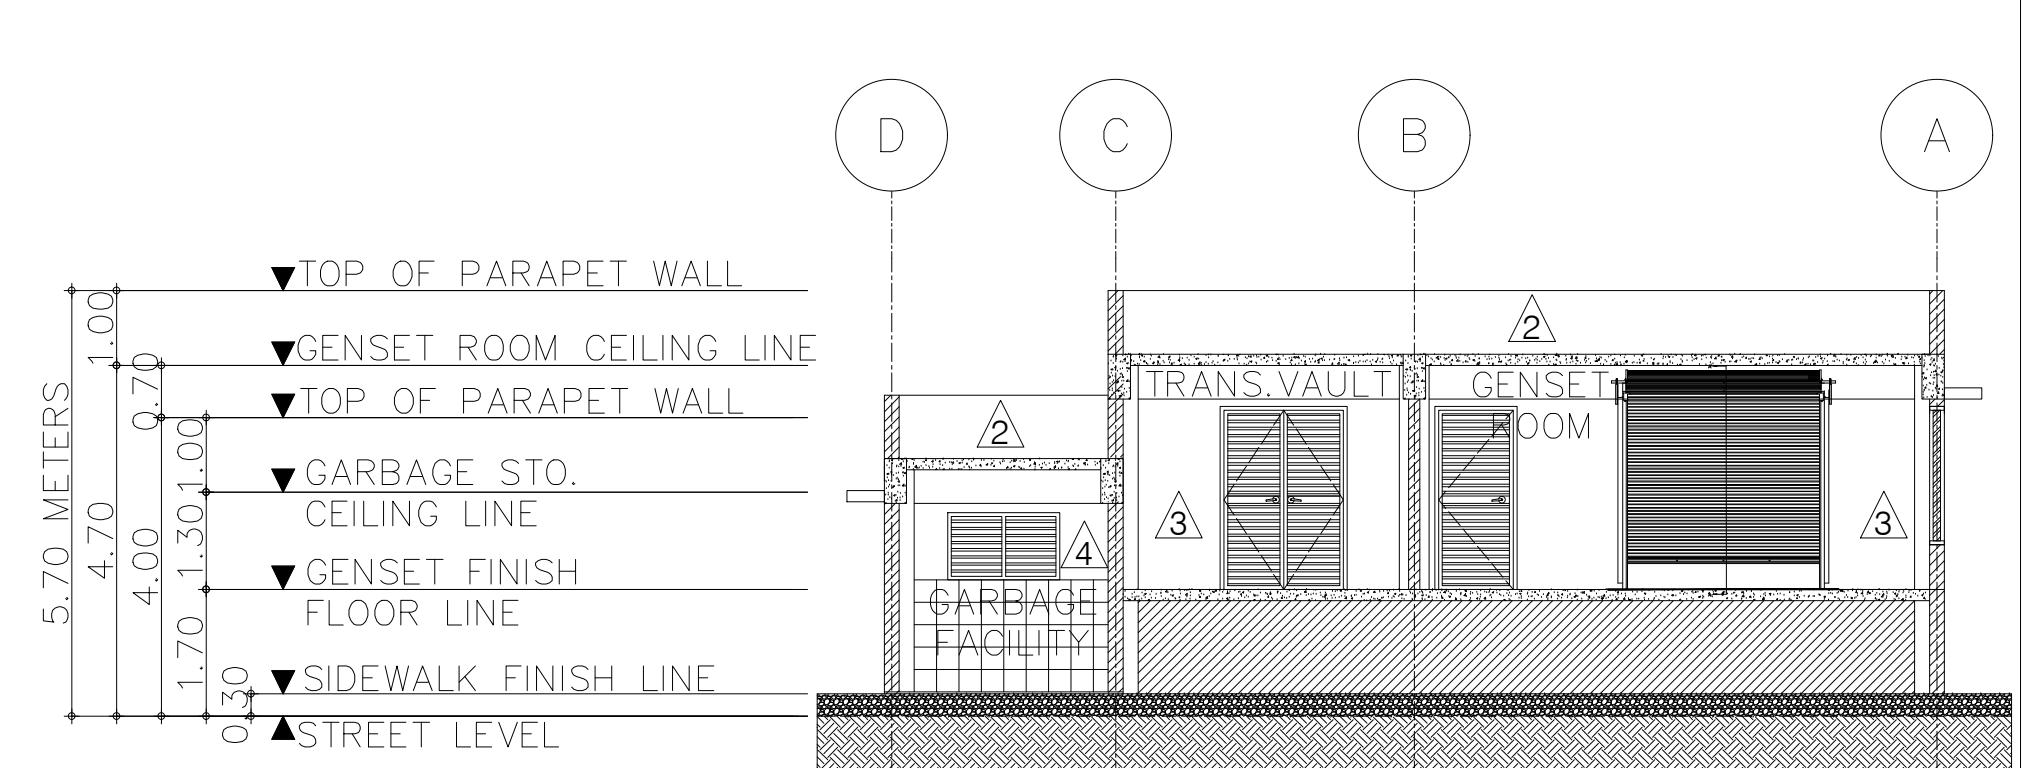


UTILITY BUILDING  
LONGITUDINAL SECTION  
SCALE 1:100M

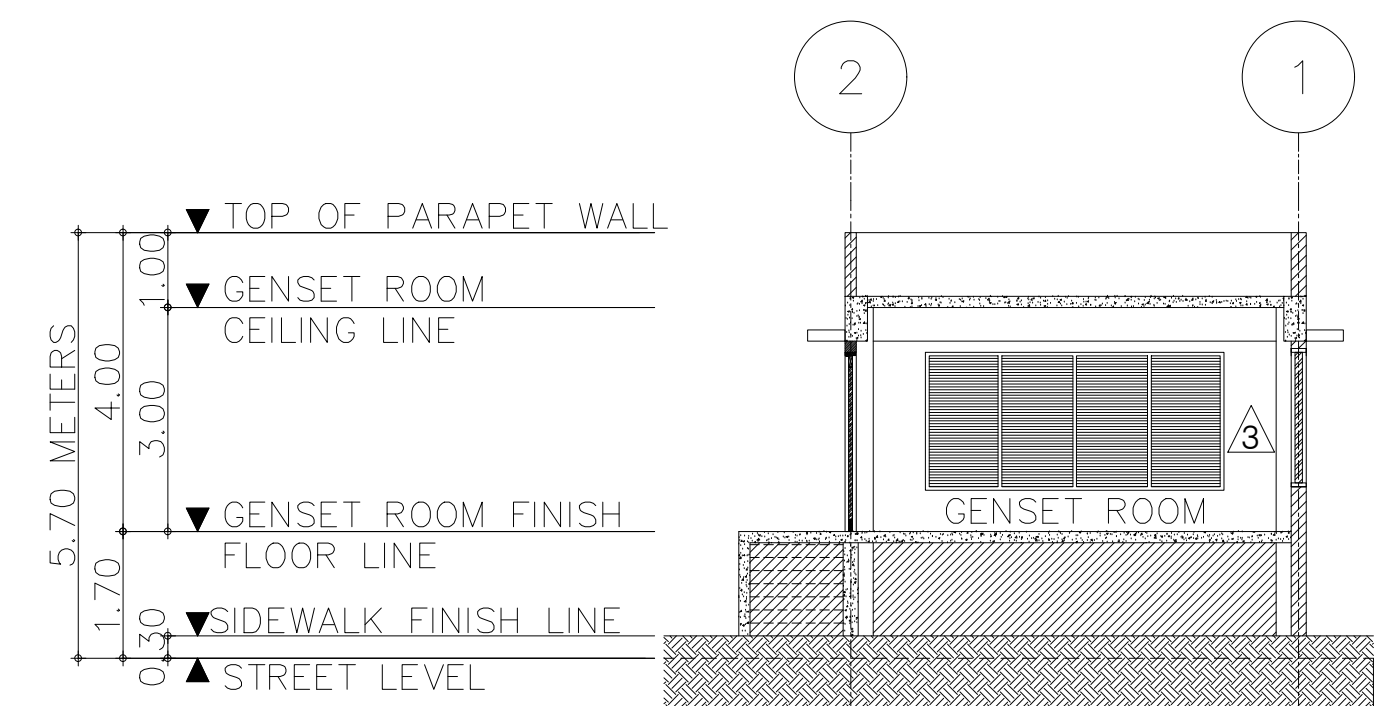


UTILITY BUILDING  
CROSS SECTION  
SCALE 1:100M

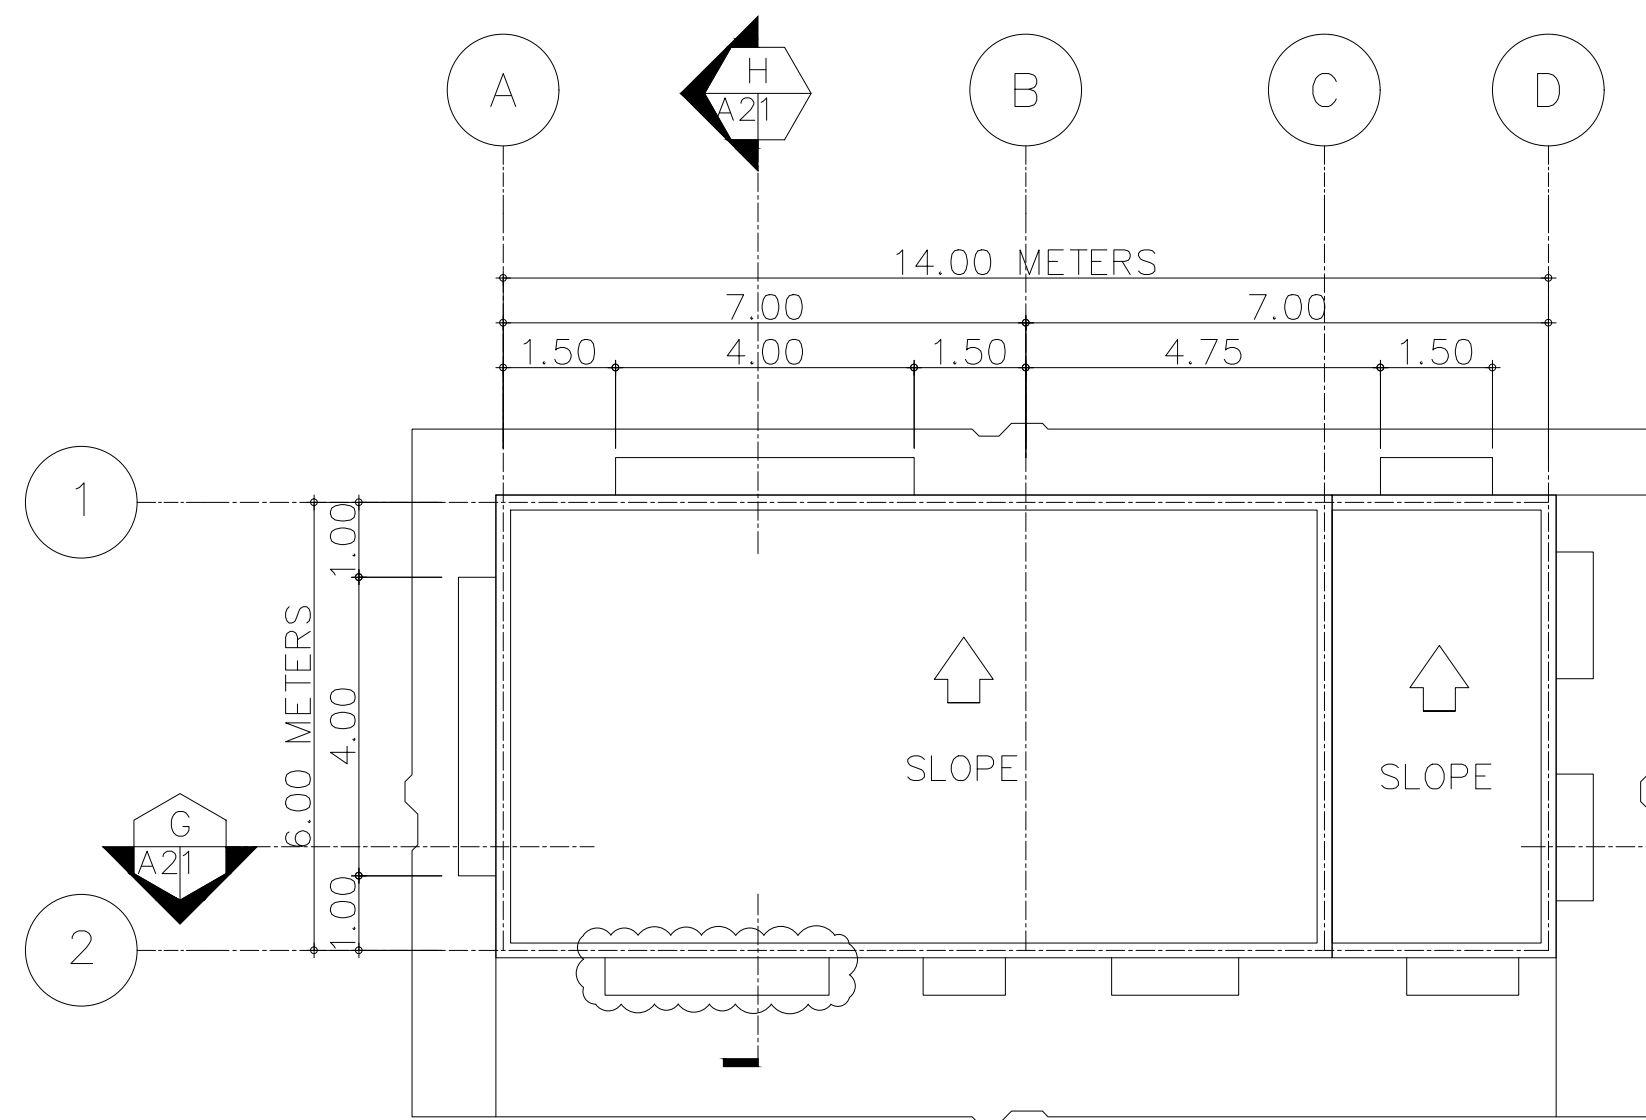

UTILITY BUILDING  
ROOF PLAN  
SCALE 1:100M

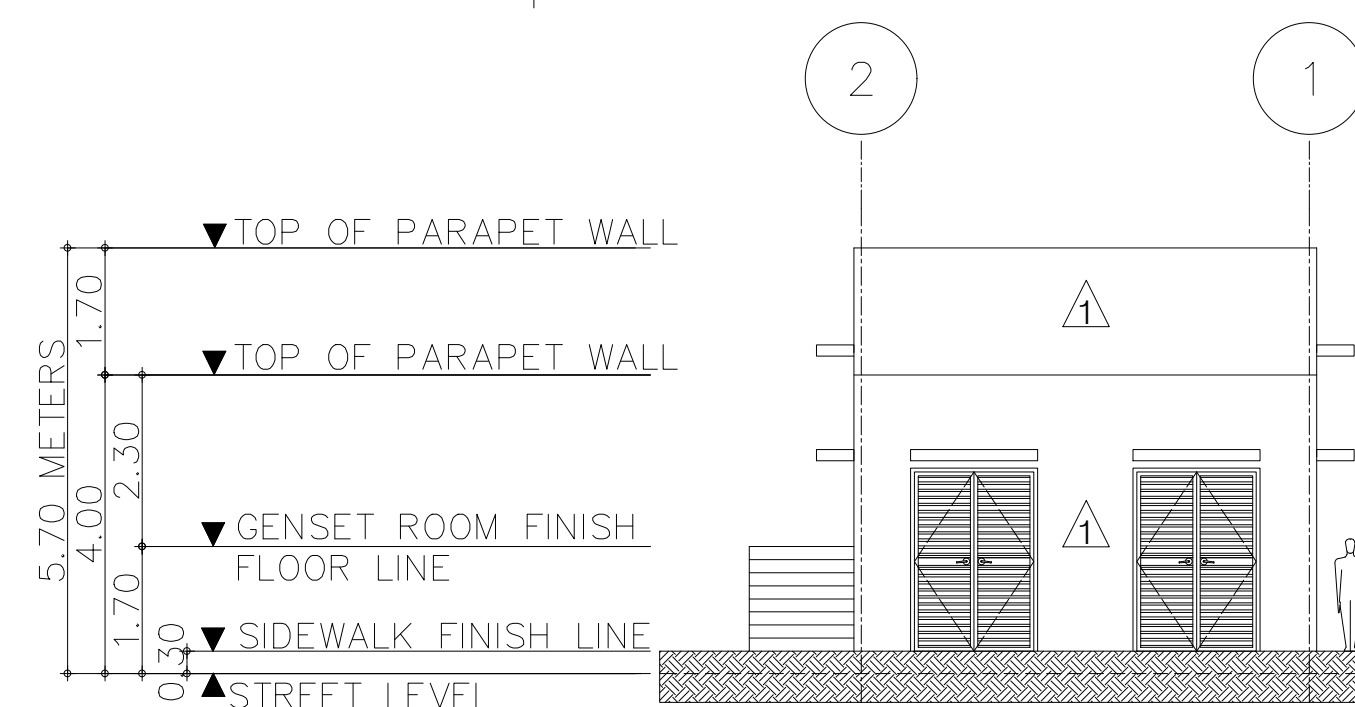


UTILITY BUILDING  
RIGHT ELEVATION  
SCALE 1:100M

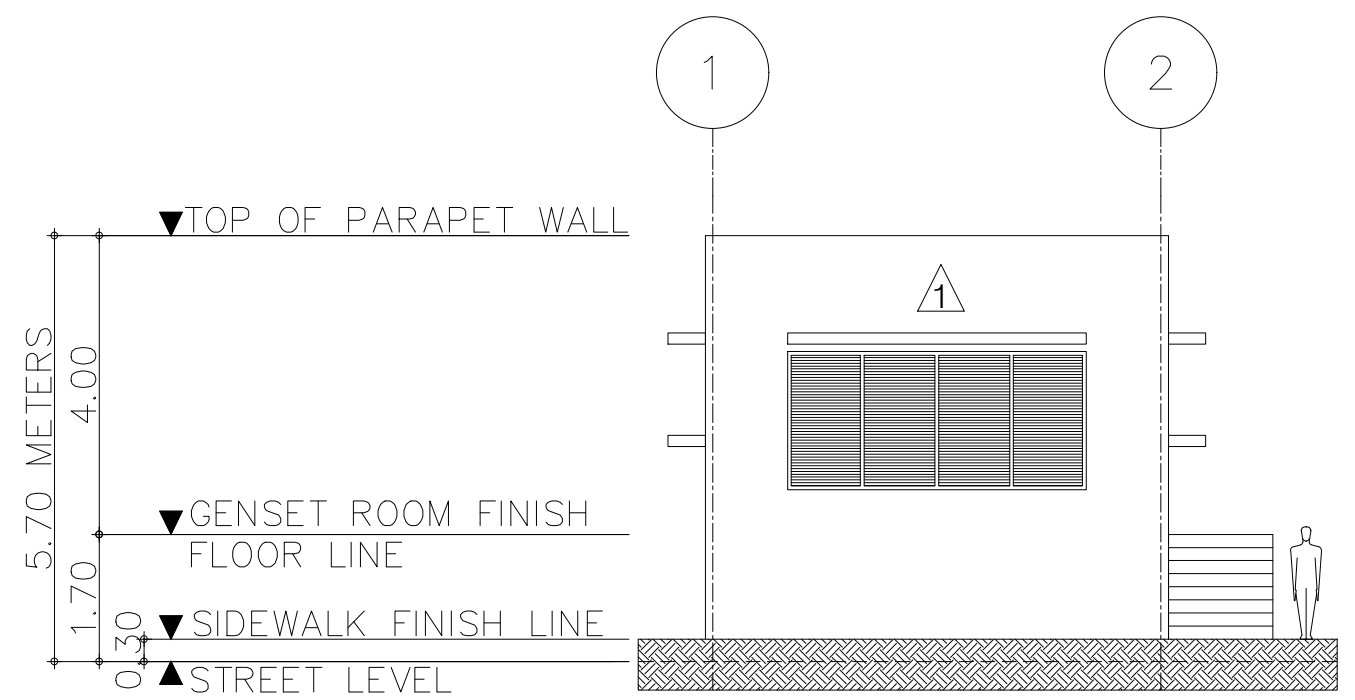

UTILITY BUILDING  
LEFT ELEVATION  
SCALE 1:100M

UTILITY BUILDING  
SCALE AS SHOWN

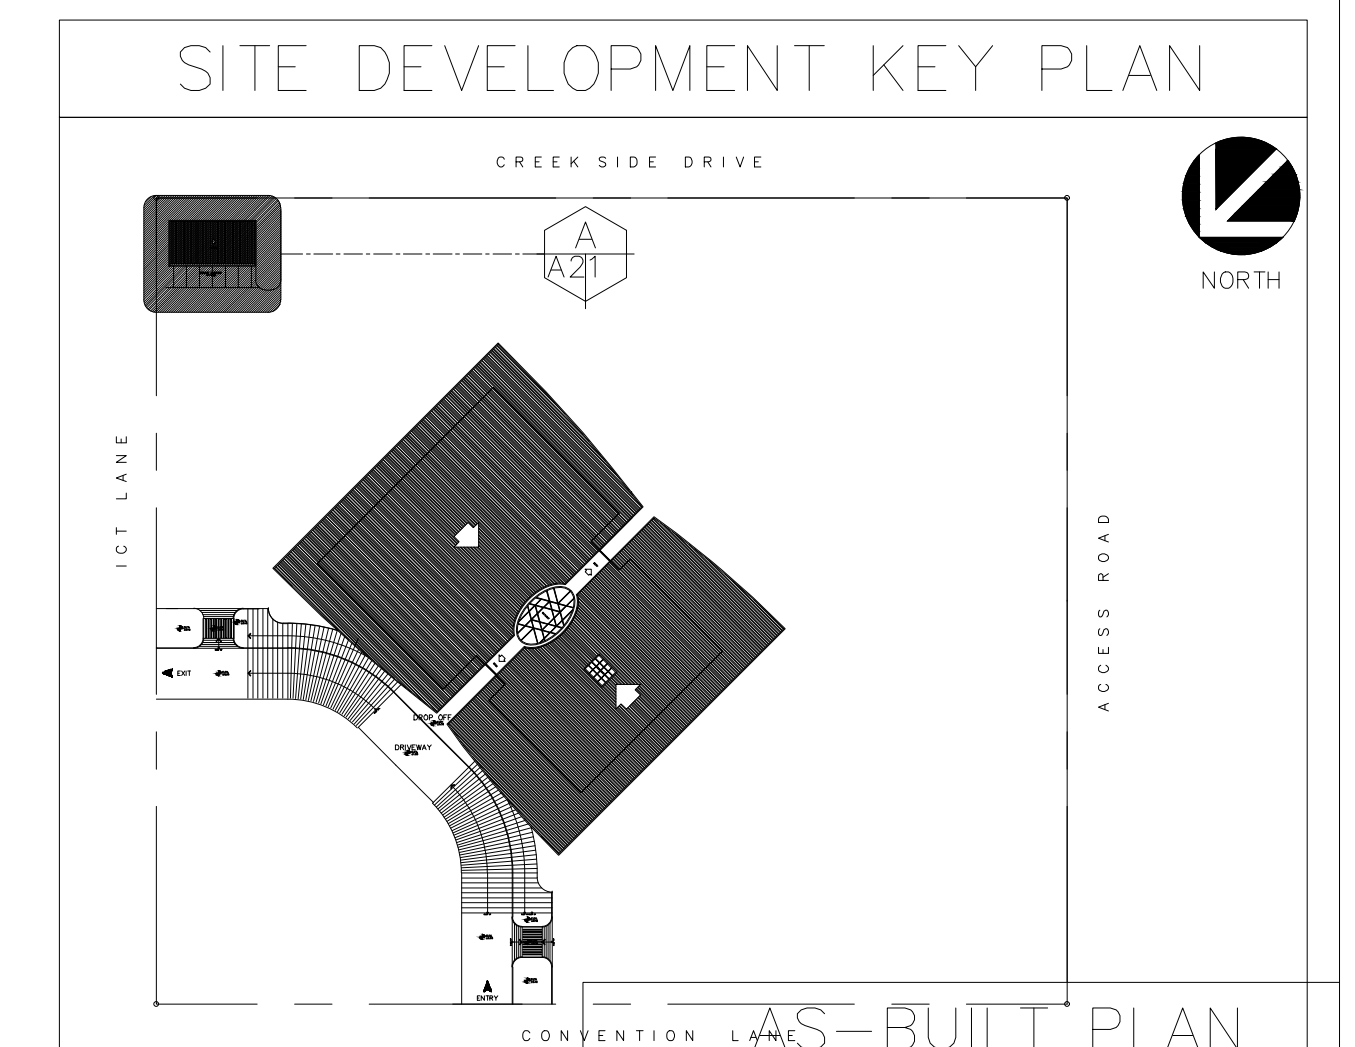

CONSULTANT	CONTRACTOR	PROJECT TITLE	OWNER	APPROVED BY :	DATE 8-21-19	SHEET NO.
ARCE•BAILON•ARCE ARCHITECTS•ENGINEERS•CONSULTANTS 14 SCOUT BORROMEO STREET, SOUTH TRIANGLE, QUEZON CITY. TRUNKLINE: 3552323 FAX NO.: 3551080 www.arcebailonarce.com	<b>ROGENOX CONSTRUCTION AND SUPPLY CORPORATION</b> #9 S. Velasco St. Phase V AFPOVAL, Taguig City, Metro Manila Tel No. 382-0599 e-mail: rogenox_rusi@yahoo.com	<b>CONSTRUCTION OF UPOU INTERNATIONAL CONVENTION CENTER</b>  UPOU CAMPUS, BRGY. MAAHAS, LOS BANOS, LAGUNA	UNIVERSITY OF THE PHILIPPINES OPEN UNIVERSITY	FRANCISCO S. BRAVO PRESIDENT / CEO, CONTRACTOR	DRAWN _____ CAD _____ CHECKED _____	A2-1



